


MCC B1-P1/P2
2X3/C-4/0, 1KV, TECK.

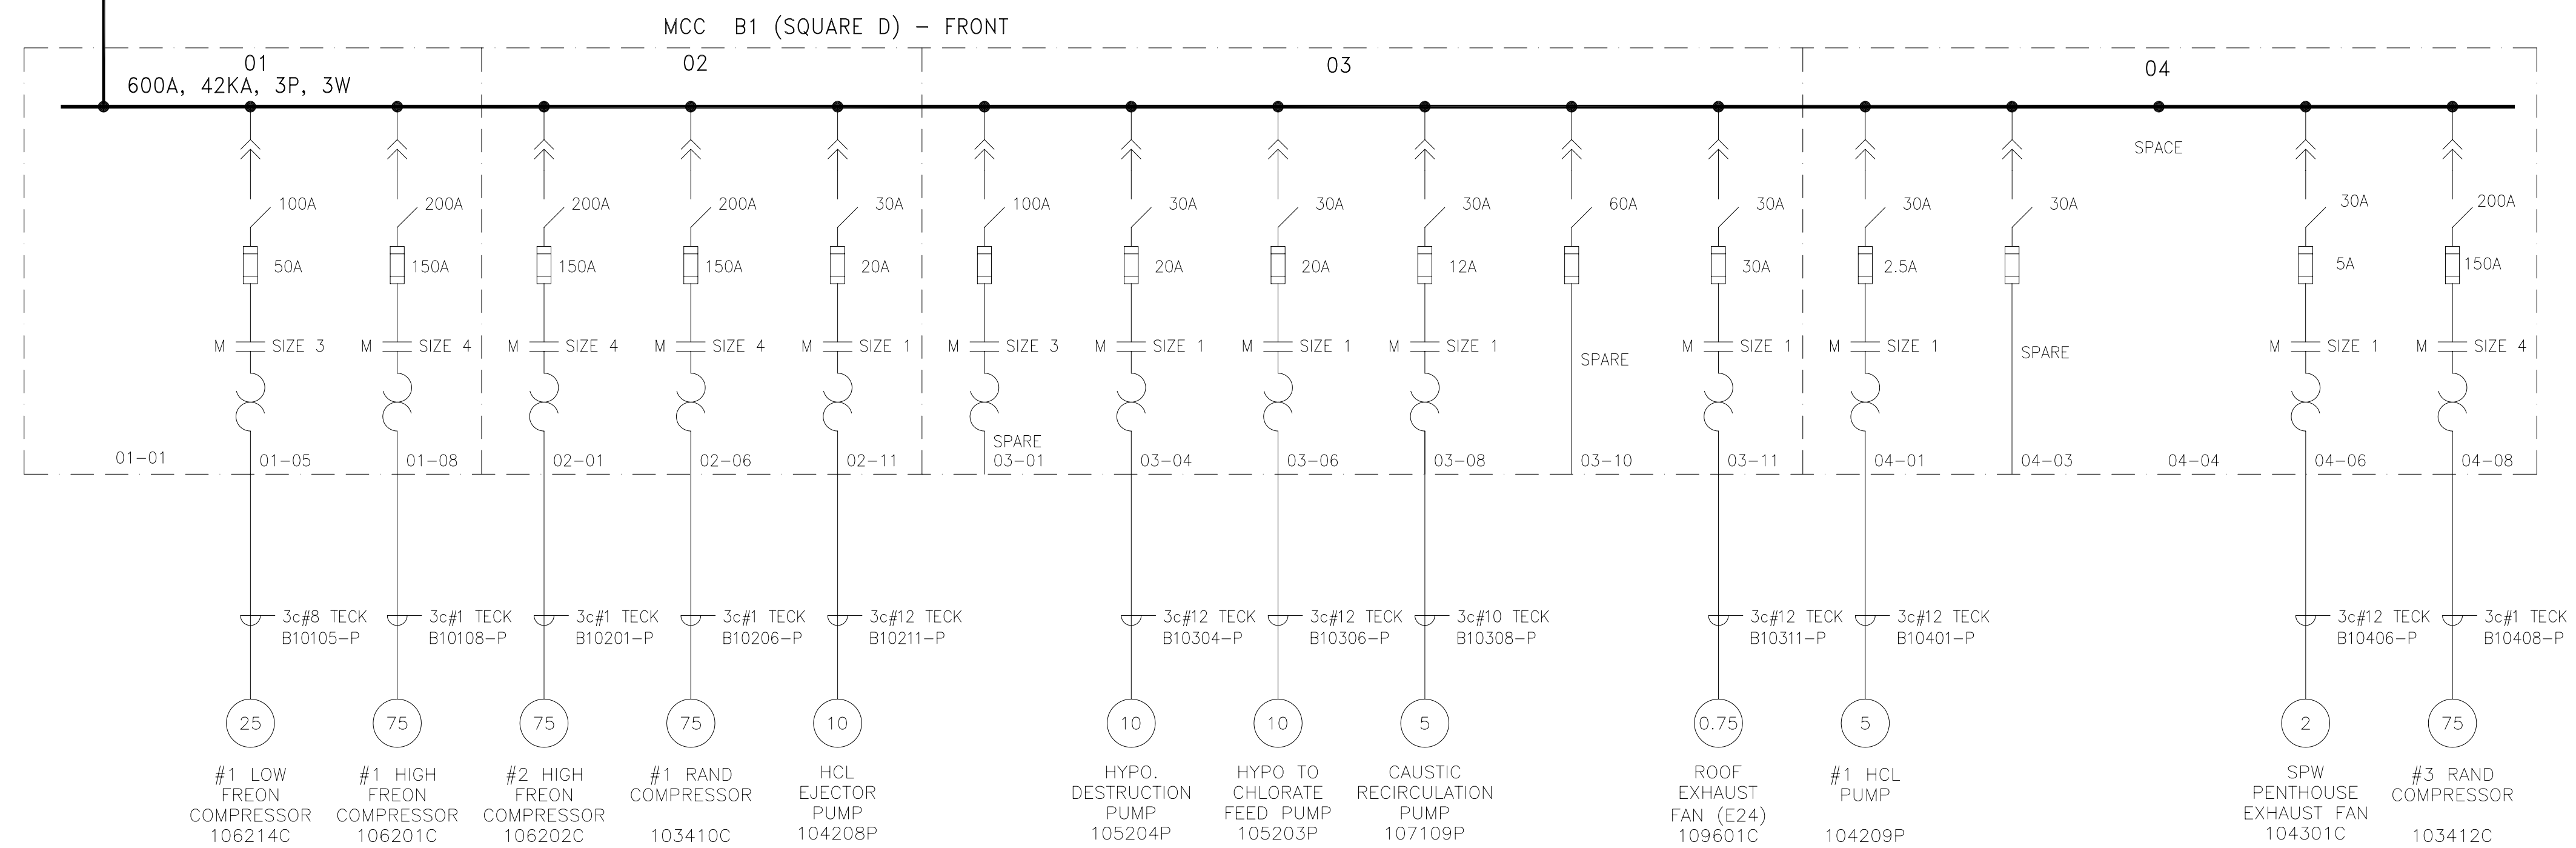

| No. | DATE | BY | DESCRIPTION | CHKD. |
|-----|--------------|-----|-------------------------|-------|
| 0 | 19 OCT 2000 | RJA | ISSUED FOR CONSTRUCTION | |
| A | 20 SEPT 2000 | JMH | ISSUED FOR TENDER | |

| REVISIONS | |
|-----------|--|
| | |
| | |
| | |
| | |

DWG. No. TITLE

REFERENCE DRAWINGS

PRELIMINARY - NOT FOR CONSTRUCTION

APPROVED FOR CONSTRUCTION

SUPERSEDES ALL PREVIOUS ISSUES

| BY | DATE |
|---------------------------|----------------------------------|
| DESIGNED IJB | DRAWN JMH |
| CHECKED DESIGN | DATE 24 AUG, 2000 |
| DRAFTING | SCALE NTS |
| PROJECT MANAGER IJB | SPECIFICATION No. 10011-IS-02 |
| PROJECT TECHNICIAN RJA | |



MCC UPGRADE PROJECT

SINGLE LINE DIAGRAM
MCC B1
PHASE 1

JOB No. 10011 CONSULTANT DWG. No.

DWG. No. 10011-002 SHT. 1